

Notes

James F Stephen Architects is a trading name of JFS Architects LLP, a Limited Liability Partnership, registered in Scotland No SO000956 whose registered office is at Milton Studio, Glamis, Angus DD8 1RG


Ordnance Survey information reproduced by permission of Ordnance Survey on behalf of HMSO. Ordnance Survey © Crown Copyright 2019 All rights reserved. Licence number 100039143

Do not scale dimensions from this drawing, all dimensions to be verified on site.


Note:

This drawing is to be read in conjunction with


Detail Elemental Specification

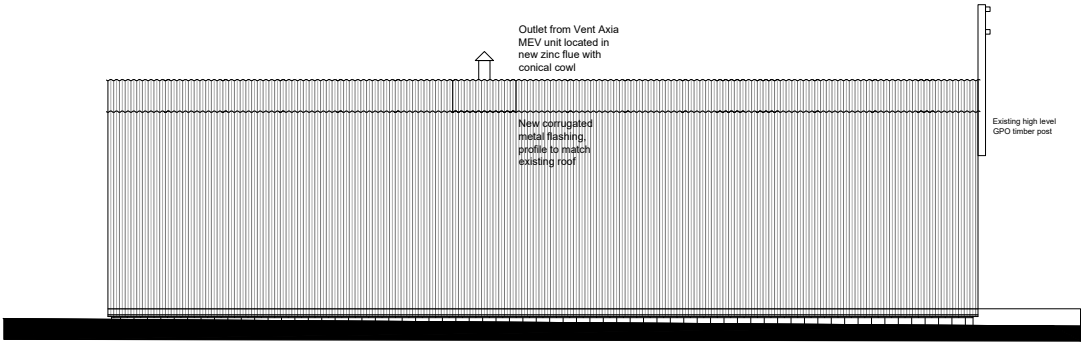


SIDE ELEVATION (SOUTH-EAST)
Scale 1:50

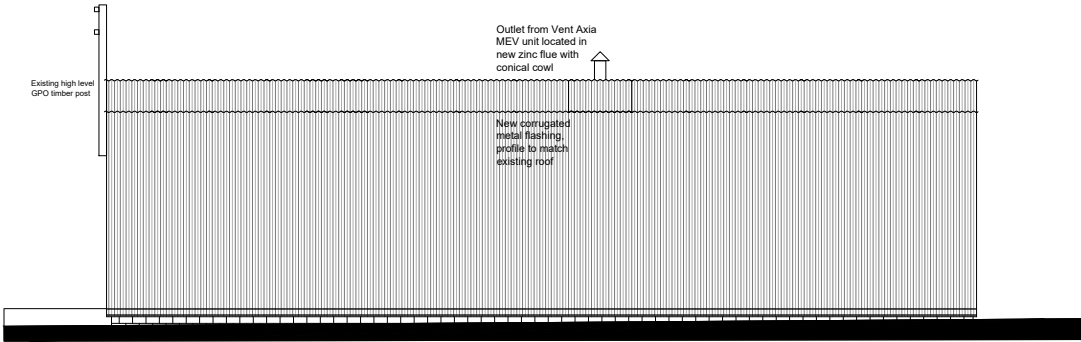


SIDE ELEVATION (NORTH-WEST)
Scale 1:50

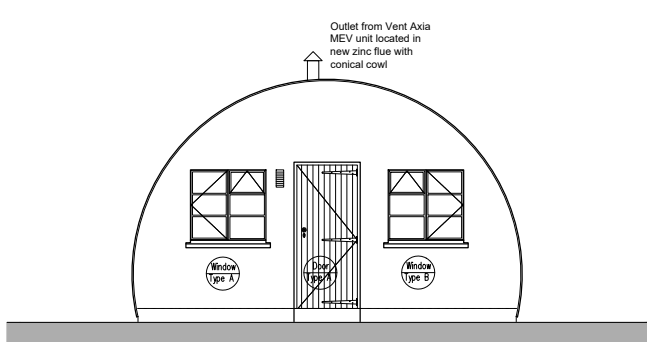


REAR ELEVATION (SOUTH-WEST)
Scale 1:50

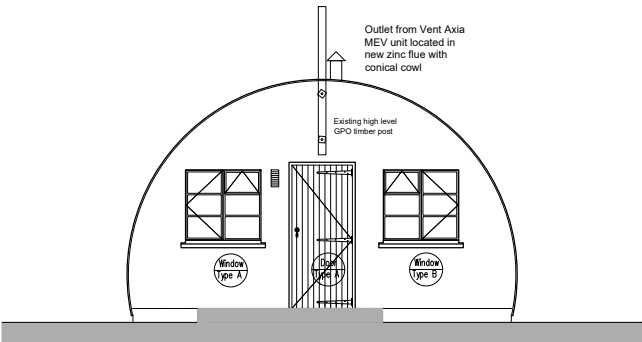


FRONT ELEVATION (NORTH-EAST)
Scale 1:50

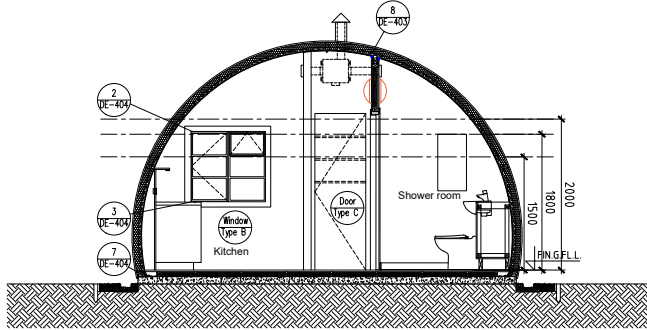

SECTION B-B
Scale 1:50

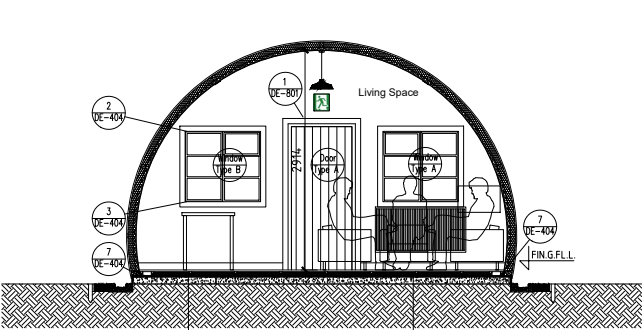


SECTION A-A
Scale 1:50

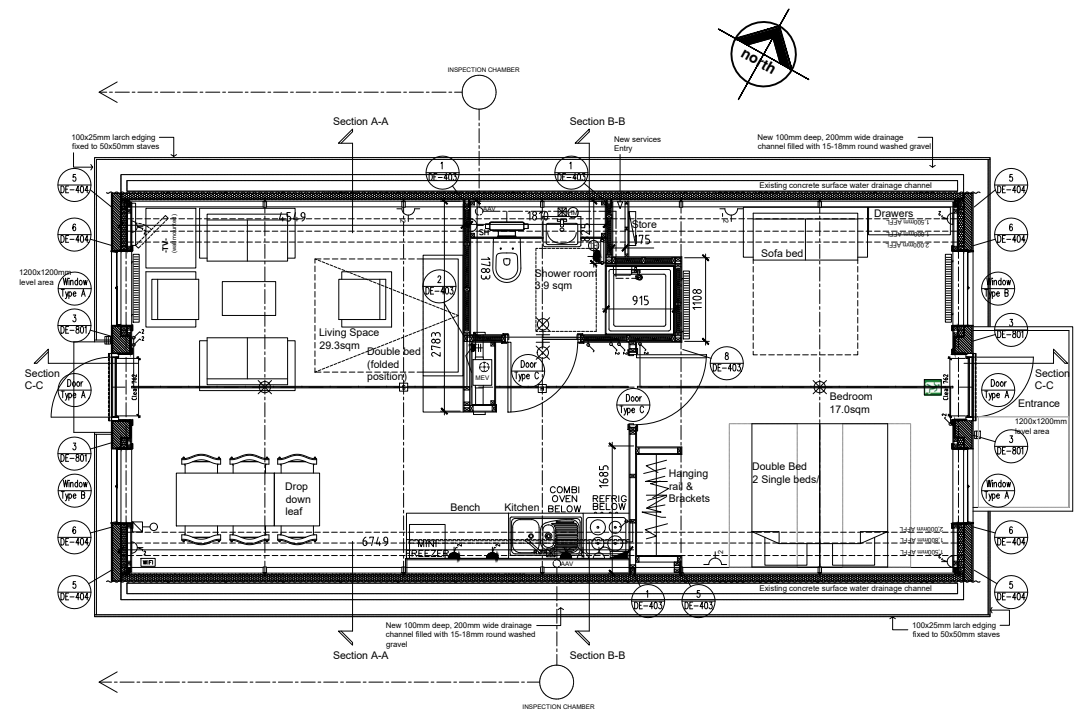


PROPOSED PLAN
Scale 1:50

- ELECTRICAL LEGEND
- DOUBLE GANG 13A SWITCHED SOCKET OUTLET (500 ABOVE FLOOR LEVEL TO CENTRE)
 - DOUBLE GANG 13A SWITCHED SOCKET OUTLET (300 ABOVE WORKTOP LEVEL TO CENTRE)
 - ENGRAVED COOKER CONTROL UNIT WITH NEON INDICATOR (300 ABOVE WORKTOP LEVEL TO CENTRE) CONNECTED TO COOKER CONNECTION POINT (500 ABOVE FLOOR LEVEL TO CENTRE)
 - ENGRAVED ISOLATOR SWITCH WITH NEON INDICATOR (300 ABOVE WORKTOP LEVEL TO CENTRE) CONNECTED TO 13A UNSWITCHED SOCKET OUTLET (500 ABOVE FLOOR LEVEL TO CENTRE) FOR APPLIANCES (WASHING MACHINE, FRIDGE/FREEZER, DISHWASHER)
 - 1-WAY LIGHT SWITCH (1200 ABOVE FLOOR LEVEL TO CENTRE)
 - 2-WAY LIGHT SWITCH (1200 ABOVE FLOOR LEVEL TO CENTRE)
 - PULLCORD LIGHT SWITCH
 - PENDANT LIGHT FITTING
 - WATER HEATING CONTROLLER (300 ABOVE WORKTOP LEVEL TO CENTRE)
 - CEILING MOUNTED SMOKE ALARM (HARD WIRED WITH BATTERY BACK-UP)
 - CEILING MOUNTED HEAT DETECTOR (HARD WIRED WITH BATTERY BACK-UP)
 - KITCHEN & SHOWER ROOM MECHANICAL VENTILATION WALL MOUNTED VENT AXIA WHIRL HOUSE VENT UNIT DUCTED TO OUTSIDE VIA EITHER UPVC RIGID OR FLEXIBLE DUCTING TERMINATING IN NEW DEDICATED ZINC FLUE WITH CONICAL COWL
 - SHOWER SOCKET
 - CONSUMER UNIT WITH E.L.M.C.B.
 - 2 GANG 13A SWITCHED SOCKET FLOOR OUTLET
 - ELECTRICITY METER
 - ILLUMINATED EXIT SIGN
 - SURFACE MOUNTED EXTERIOR LIGHT FITTING WITH INTEGRAL PIR (IP65 CLASSIFICATION)
 - UNDER CABINET LED STRIP LIGHTING
 - WALL MOUNTED LIGHT FITTING

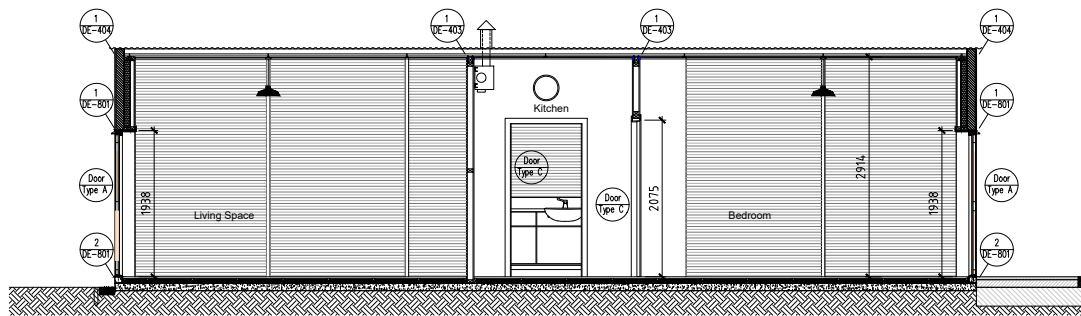

SECTION C-C
Scale 1:50

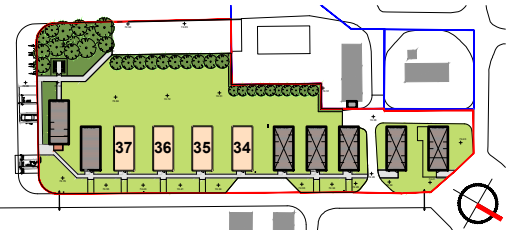

BLOCK PLAN
Scale 1:1000

FOR CONSTRUCTION

rev. date details drwn chkd

James F Stephen Architects
Incorporating Baxter, Clark & Paul (Dundee)
Architecture - Interior Design - Landscape Design

Milton Studio

www.jfsa.co.uk
Glamis Angus DD8 1RG t. 01307 475000
5 Viewfield Pl. Stirling FK8 1NQ t. 01786 446939

Job Title
Camp 21 Heritage Self Catering Accommodation
at Cultybraggan Camp, Comrie
Perthshire
for Comrie Development Trust

Drawing Title
4 Bed Self Catering Hut - Typical layout
Proposed Plan, Sections & Elevations

Scale. 1:50 Drwn. DP
Original Size. A1 Chkd. DJR
© JFS Architects LLP Date. 26/11/2019

Drawing No.
4032-GA-318