

Notes

James F Stephen Architects is a trading name of JFS Architects LLP, a Limited Liability Partnership, registered in Scotland No SO500956 whose registered office is at Milton Studio, Glamis, Angus DD8 1RG


Ordnance Survey information reproduced by permission of Ordnance Survey on behalf of HMSO. Ordnance Survey © Crown Copyright 2019 All rights reserved. Licence number 100039143

Do not scale dimensions from this drawing, all dimensions to be verified on site.


Note:

This drawing is to be read in conjunction with


Detail Elemental Specification

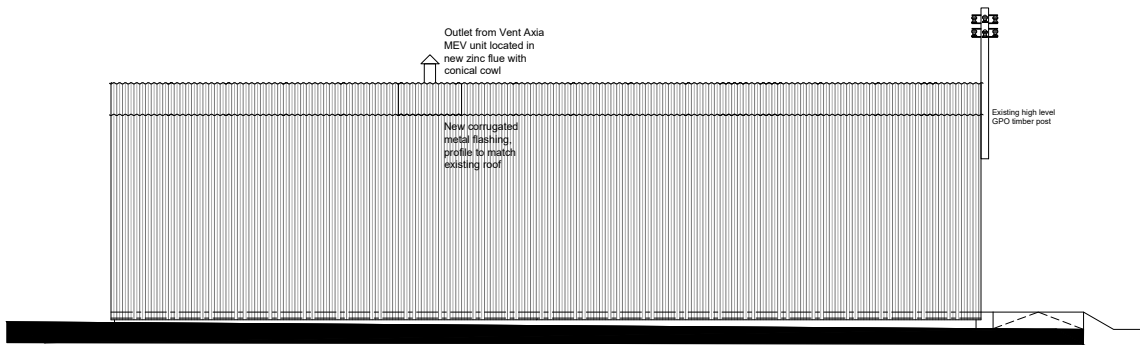


SIDE ELEVATION (SOUTH-EAST)
Scale 1:50

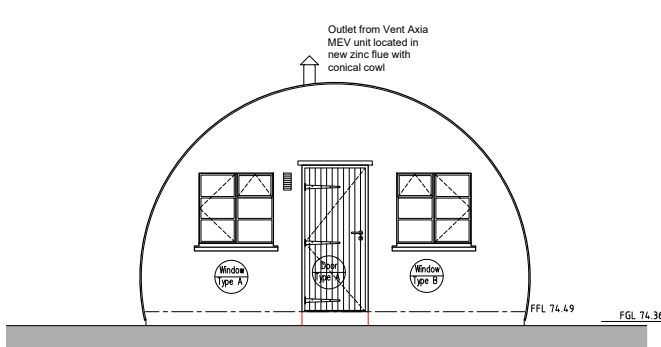


REAR ELEVATION (SOUTH-WEST)
Scale 1:50

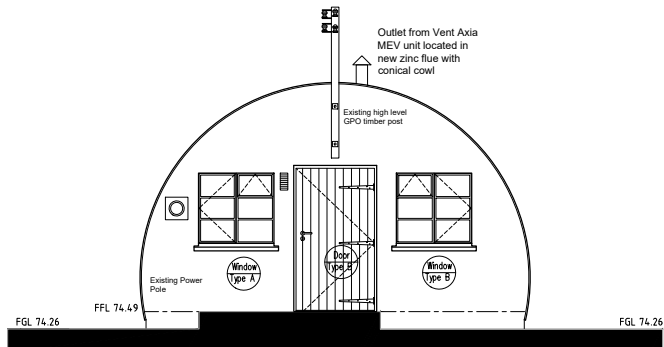


FRONT ELEVATION (NORTH-EAST)
Scale 1:50

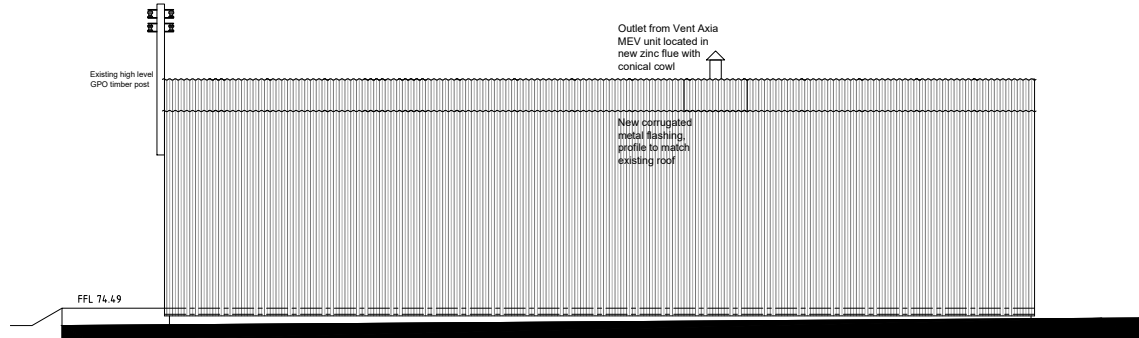


SIDE ELEVATION (NORTH-WEST)
Scale 1:50

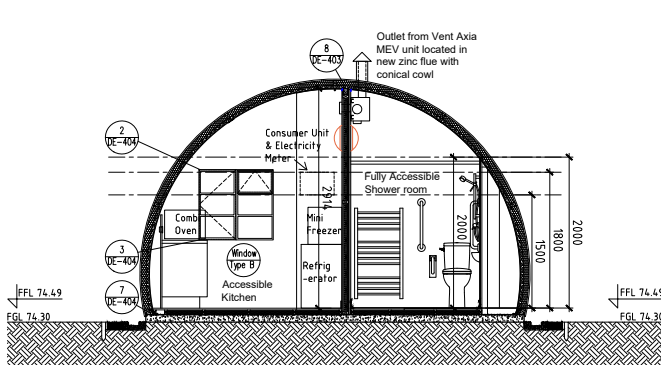


SECTION B-B
Scale 1:50

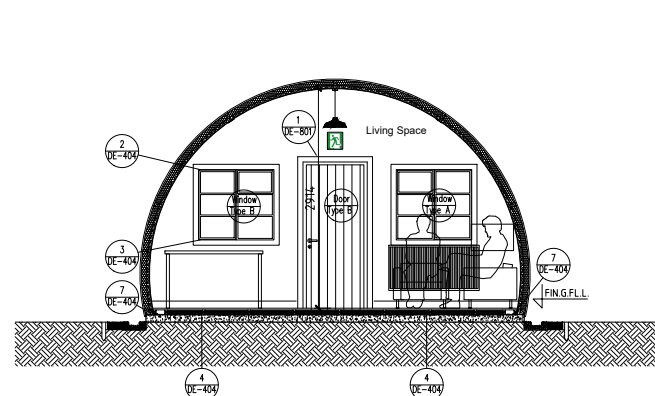


SECTION A-A
Scale 1:50

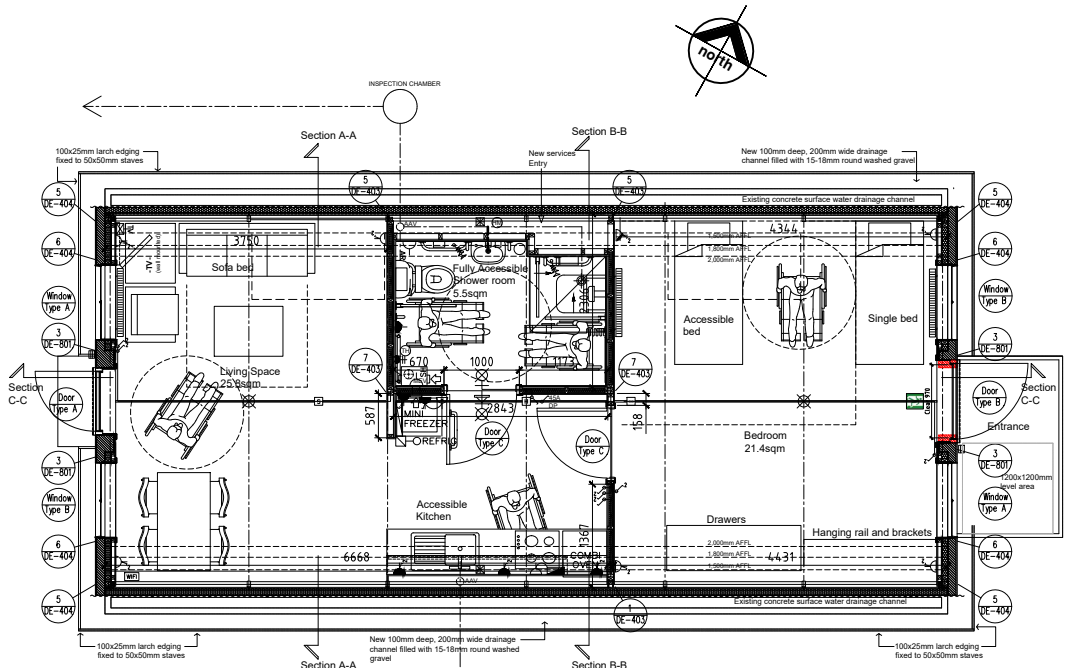

PROPOSED PLAN
Scale 1:50

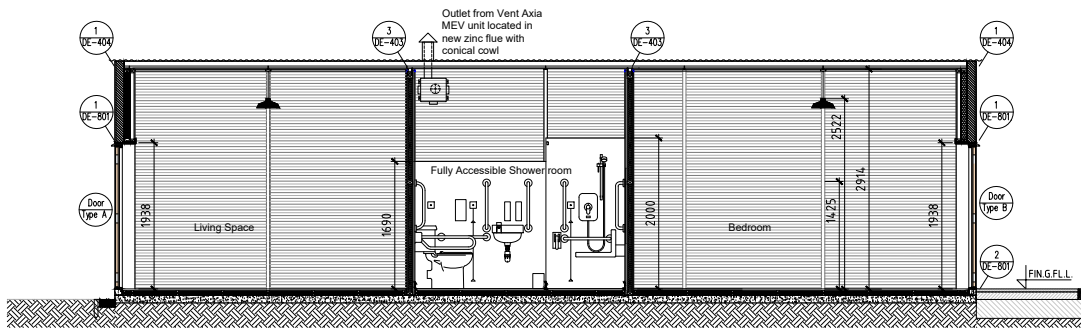

SECTION C-C
Scale 1:50

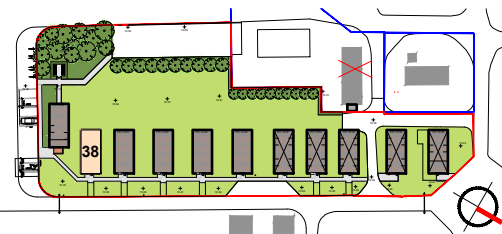

BLOCK PLAN
Scale 1:1000

- ELECTRICAL LEGEND
- DOUBLE GANG 13A SWITCHED SOCKET OUTLET (500 ABOVE FLOOR LEVEL TO CENTRE).
 - DOUBLE GANG 13A SWITCHED SOCKET OUTLET (300 ABOVE WORKTOP LEVEL TO CENTRE).
 - ENGRAVED COOKER CONTROL UNIT WITH NEON INDICATOR (300 ABOVE WORKTOP LEVEL TO CENTRE) CONNECTED TO COOKER CONNECTION POINT (500 ABOVE FLOOR LEVEL TO CENTRE).
 - ENGRAVED ISOLATOR SWITCH WITH NEON INDICATOR (300 ABOVE WORKTOP LEVEL TO CENTRE) CONNECTED TO 13A UNSWITCHED SOCKET OUTLET (500 ABOVE FLOOR LEVEL TO CENTRE) FOR APPLIANCES (WASHING MACHINE, FRIDGE/FREEZER, DISHWASHER).
 - 1-WAY LIGHT SWITCH (1200 ABOVE FLOOR LEVEL TO CENTRE).
 - 2-WAY LIGHT SWITCH (1200 ABOVE FLOOR LEVEL TO CENTRE).
 - PULLCORD LIGHT SWITCH.
 - PENDANT LIGHT FITTING.
 - UNDER BENCH ELECTRIC WATER HEATER.
 - CEILING MOUNTED SMOKE ALARM (HARD WIRED WITH BATTERY BACK-UP).
 - CEILING MOUNTED HEAT DETECTOR (HARD WIRED WITH BATTERY BACK-UP).
 - KITCHEN & SHOWER ROOM MECHANICAL VENTILATION. WALL MOUNTED VENT AXIA WHOLE HOUSE VENT UNIT DUCTED TO OUTSIDE VIA EITHER UPVC RIGID OR FLEXIBLE DUCTING TERMINATING IN NEW DEDICATED ZINC FLUE WITH CONICAL COWL.
 - SWITCHED SHOWER SOCKET POINT.
 - CONSUMER UNIT WITH E.L.M.C.B.
 - ELECTRICITY METER.
 - ILLUMINATED EXIT SIGN.
 - ALARM RESET BUTTON.
 - OVERDOOR LIGHT & SOUNDER UNIT.
 - ALARM PULL CORD.
 - SURFACE MOUNTED EXTERIOR LIGHT FITTING WITH INTEGRAL PIR (IP65 CLASSIFICATION).
 - UNDER CABINET LED STRIP LIGHTING.
 - WALL MOUNTED LIGHT FITTING.
 - WIFI ROUTER.
 - WIFI ROUTER.
 - 13A SWITCHED FUSED SPUR OUTLET.
 - ELECTRIC TOWEL RAIL.
 - HEAT METER.
 - 45A DOUBLE POLE SWITCH FOR ELECTRIC SHOWER.

FOR CONSTRUCTION

rev. date details drwn chkd

James F Stephen Architects
Incorporating Baxter, Clark & Paul (Dundee)
Architecture - Interior Design - Landscape Design

Milton Studio

www.jfsa.co.uk
Glamis Angus DD8 1RG t. 01307 475000
5 Viewfield Pl. Stirling FK8 1NQ t. 01786 446939

Job Title
Camp 21 Heritage Self Catering Accommodation
at Cultybraggan Camp, Comrie
Perthshire
for Comrie Development Trust

Drawing Title
Hut 38 - Proposed Plan, Sections & Elevations
Fully Accessible Self-Catering Accommodation

Scale. 1:50 Drwn. DP
Original Size. A1 Chkd. DJR
© JFS Architects LLP Date. 27/11/2019

Drawing No.
4032-GA-319