

Notes

James F Stephen Architects is a trading name of JFS Architects LLP, a Limited Liability Partnership, registered in Scotland No SC0300956 whose registered office is at Milton Studio, Glamis, Angus DD8 1RG


Ordnance Survey information reproduced by permission of Ordnance Survey on behalf of HMSO. Ordnance Survey © Crown Copyright 2020 All rights reserved. Licence number 100039143

Do not scale dimensions from this drawing, all dimensions to be verified on site.


Note:

This drawing is to be read in conjunction with

Detailed Elemental Specification

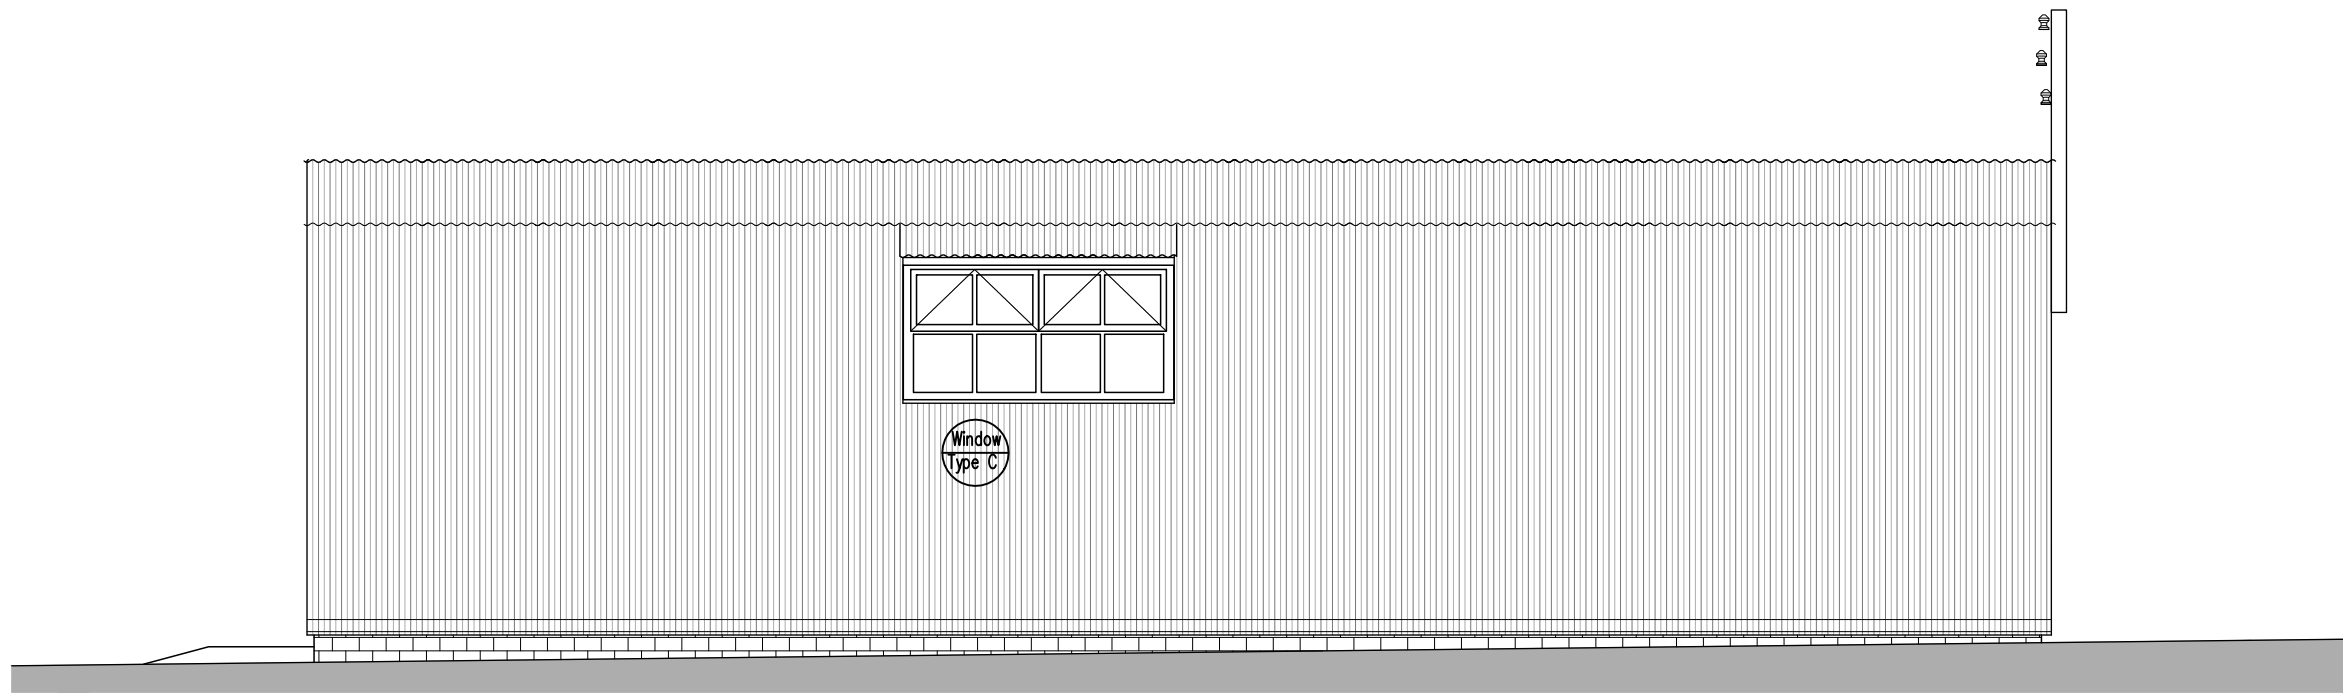


SIDE ELEVATION (SOUTH-EAST)
Scale 1:50

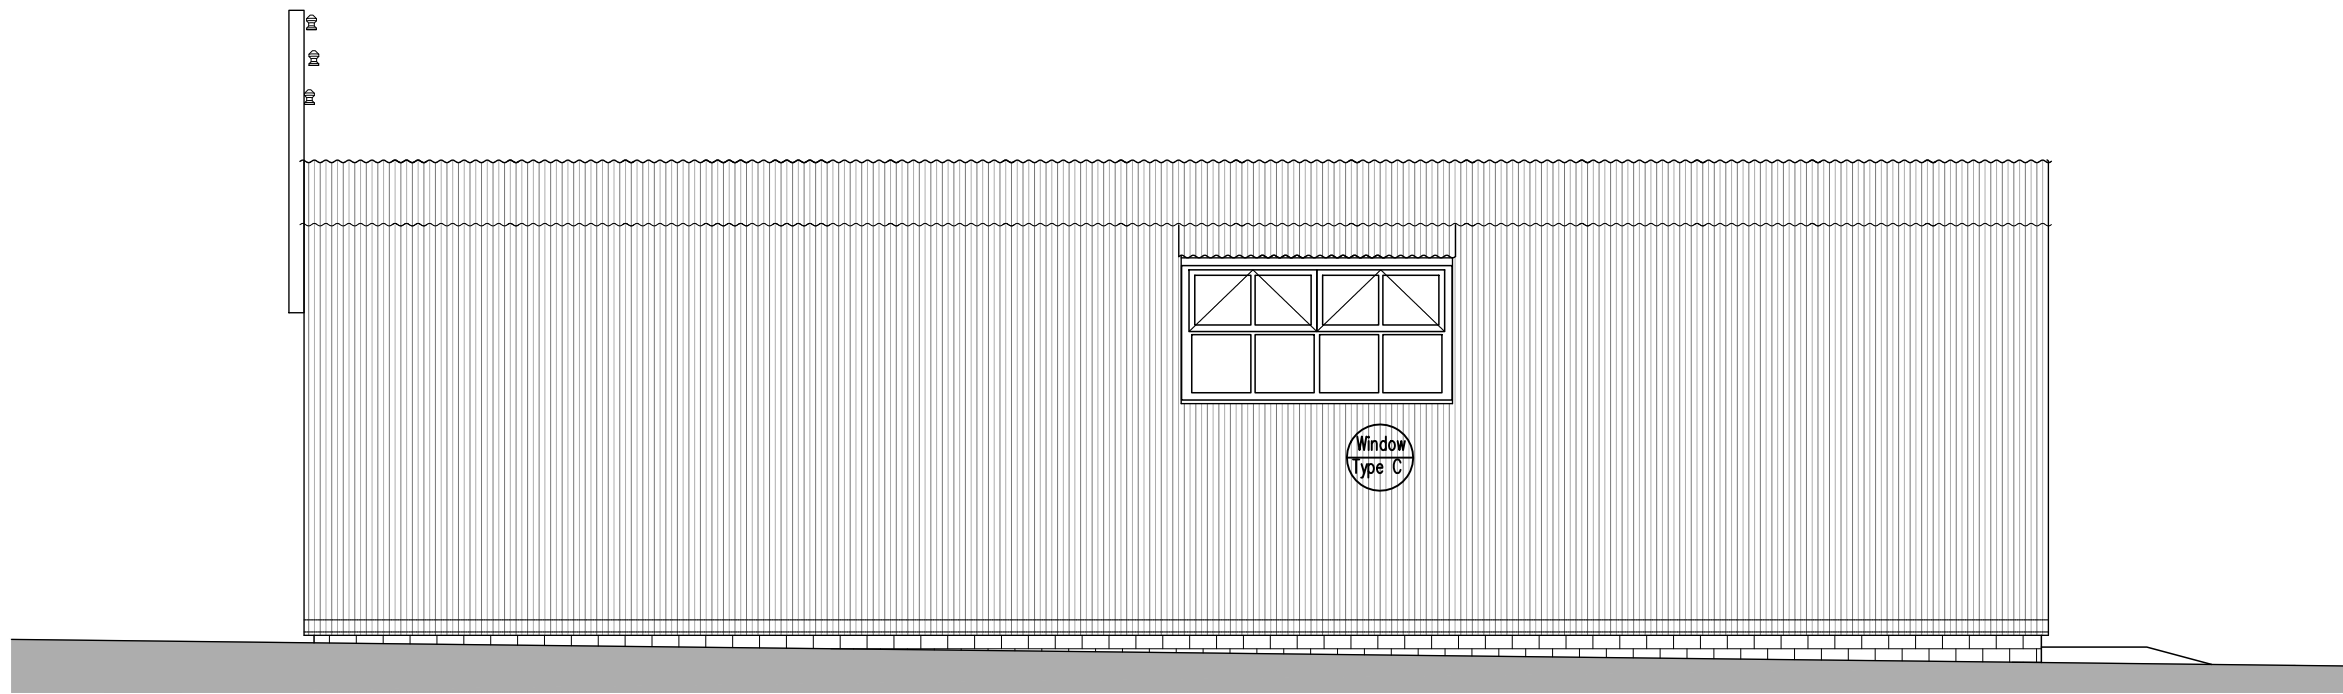


SIDE ELEVATION (NORTH-WEST)
Scale 1:50




REAR ELEVATION (SOUTH-WEST)
Scale 1:50

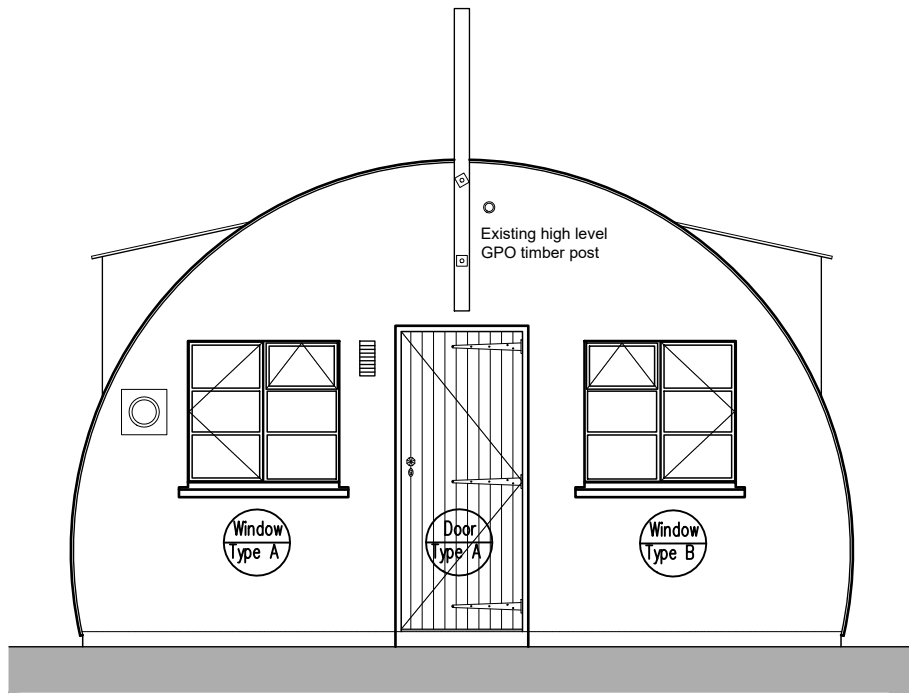


FRONT ELEVATION (NORTH-EAST)
Scale 1:50

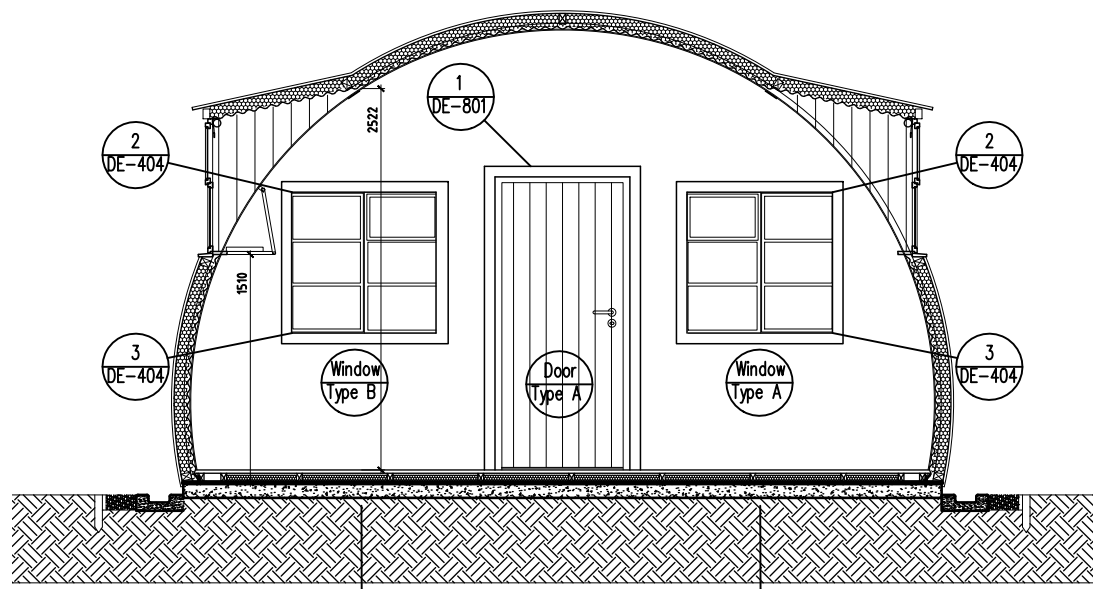

SECTION B-B
Scale 1:50

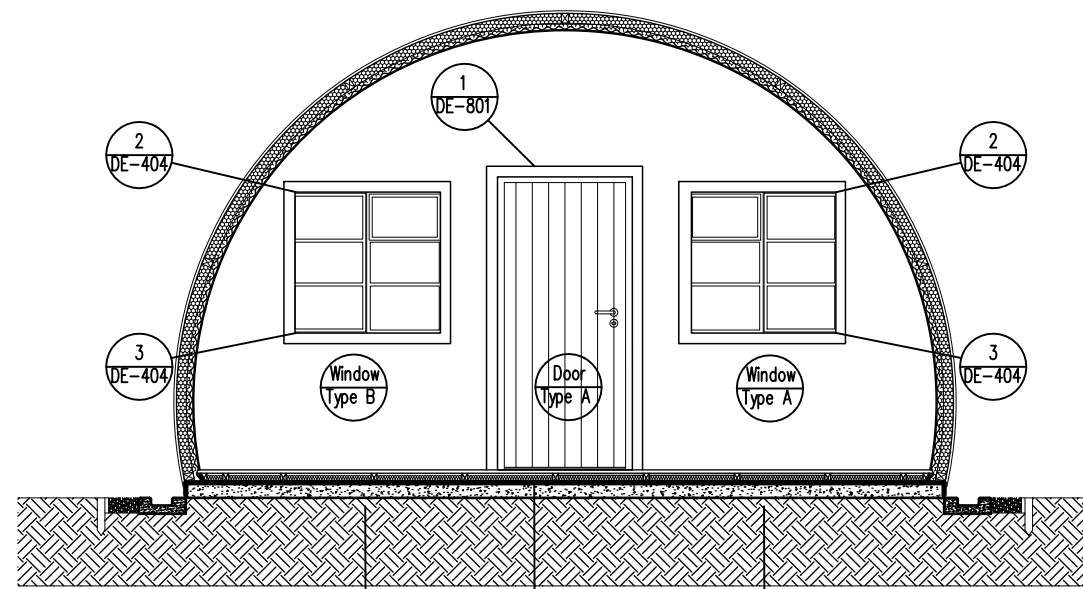


SECTION A-A
Scale 1:50

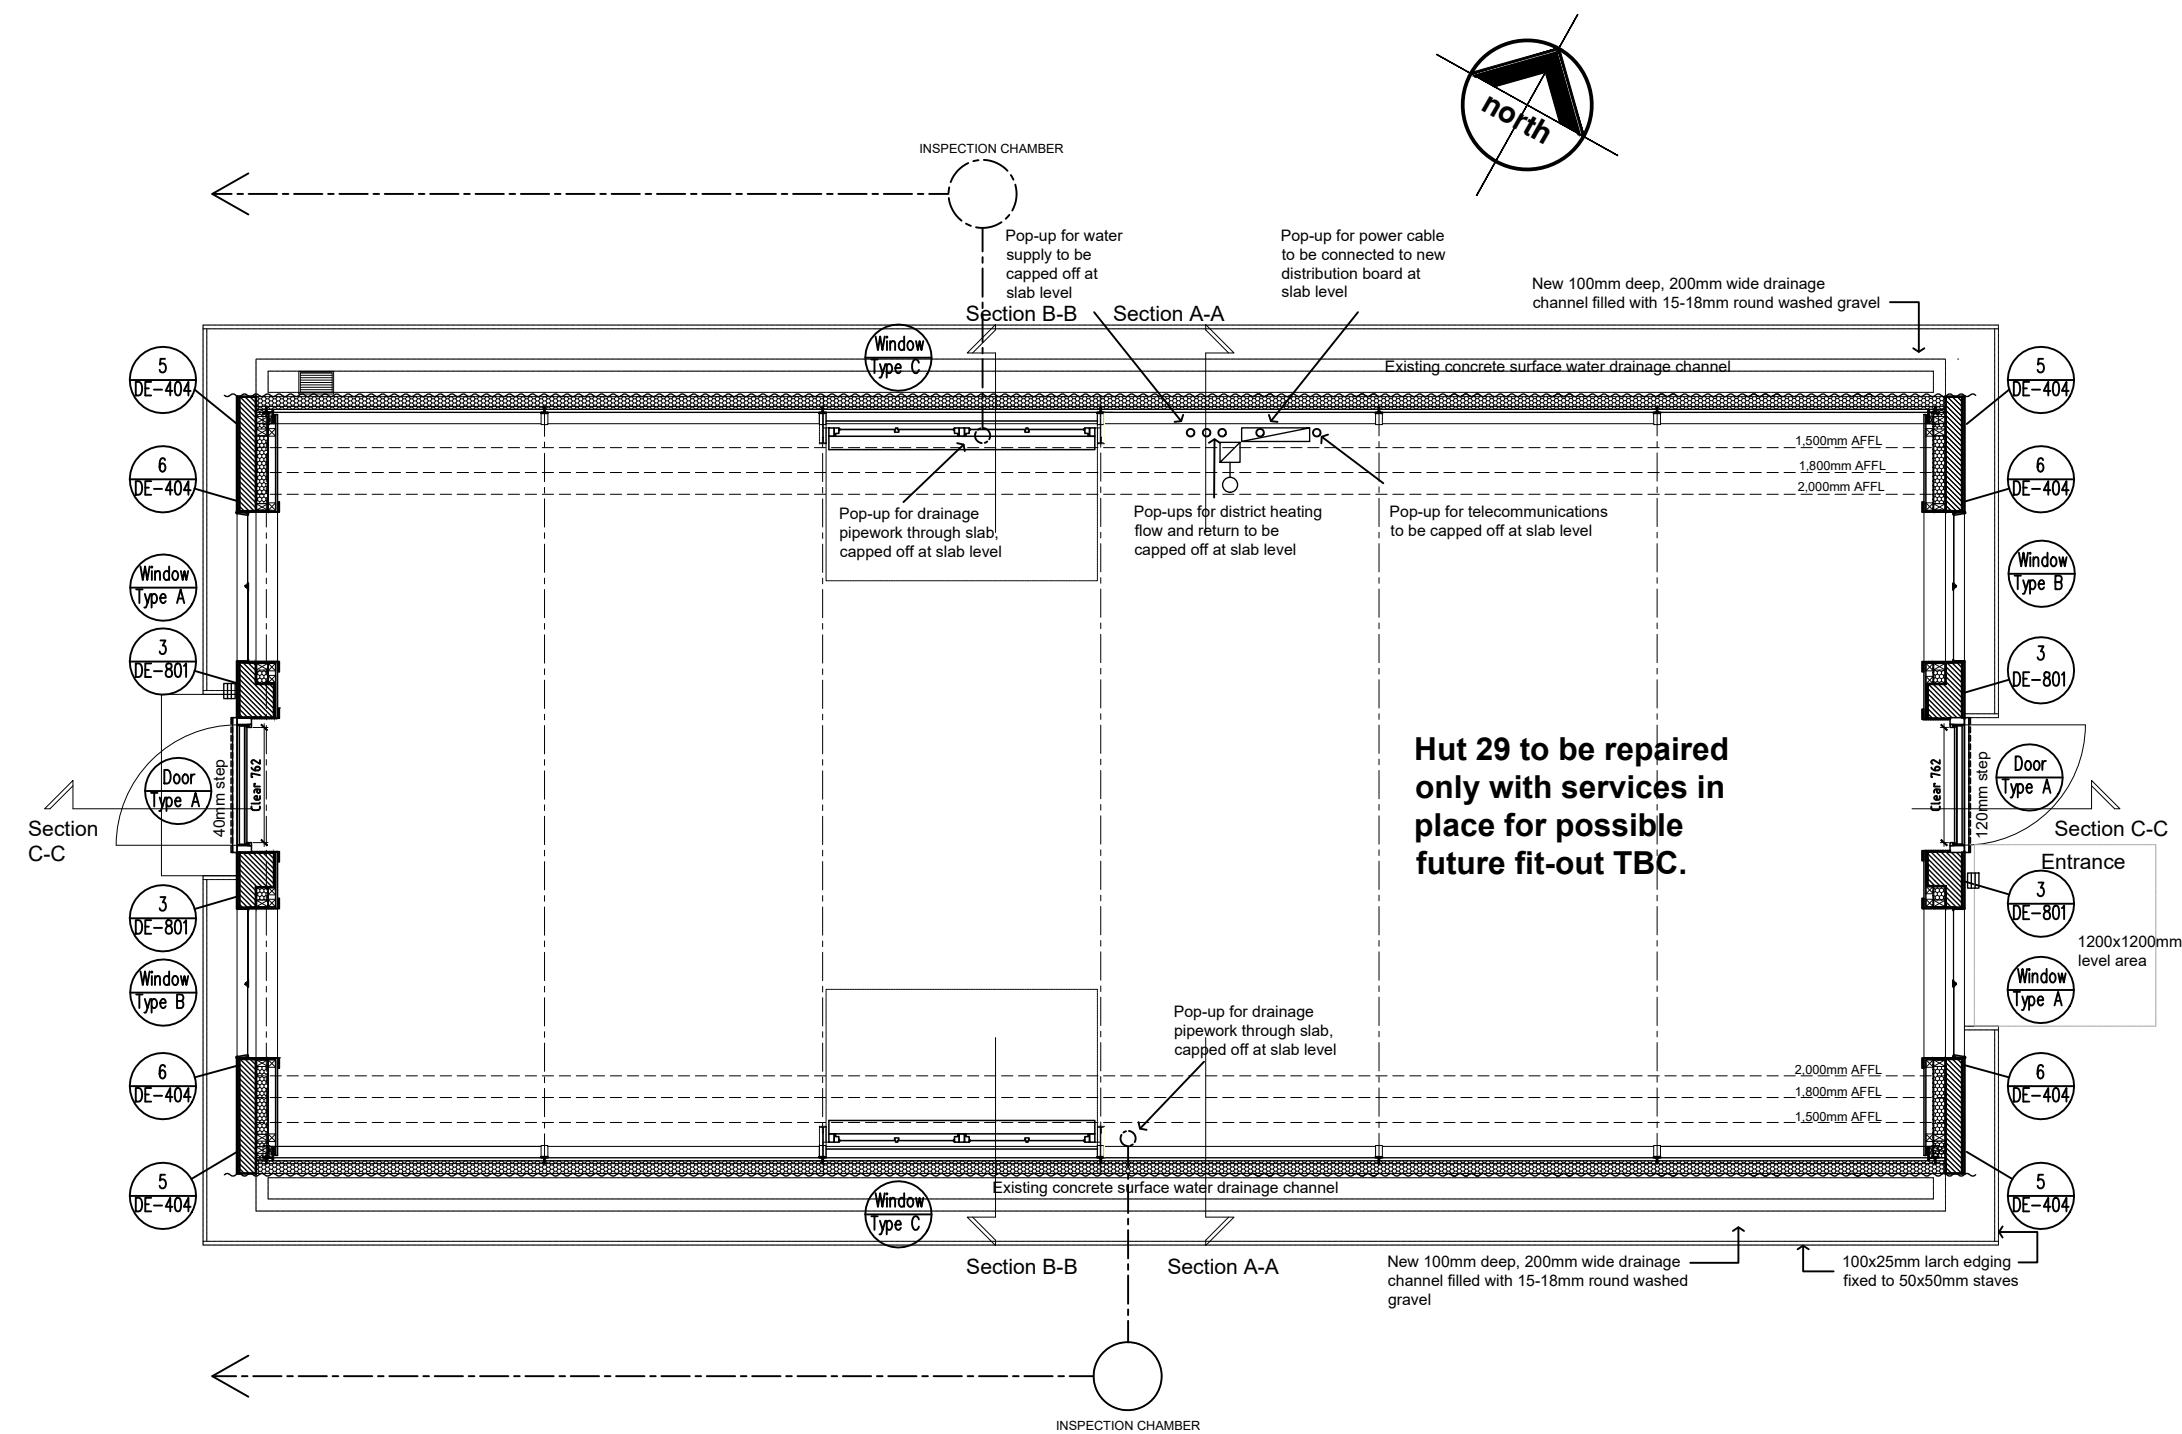


PROPOSED PLAN
Scale 1:50

- ELECTRICAL LEGEND
- CONSUMER UNIT WITH ELN.C.B.
 - ELECTRICITY METER
 - SURFACE MOUNTED EXTERIOR LIGHT FITTING WITH INTEGRAL PIR (IP65 CLASSIFICATION)

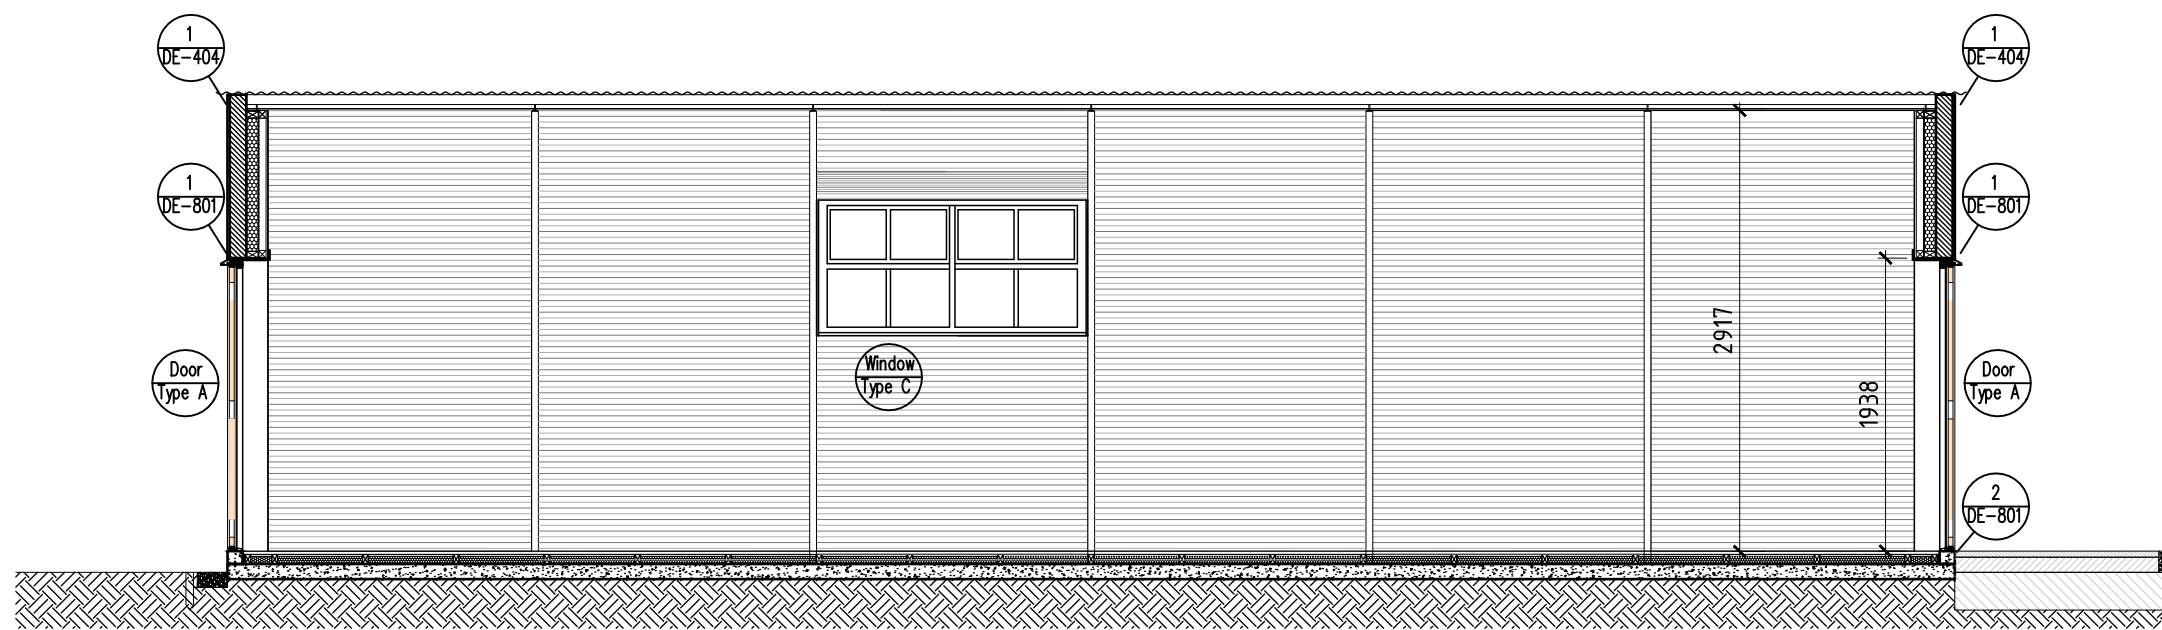

SECTION C-C
Scale 1:50

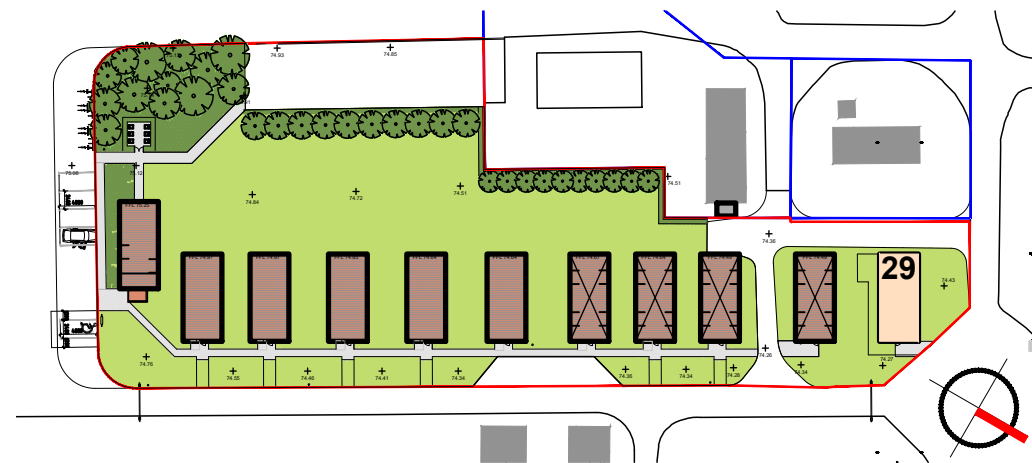

BLOCK PLAN
Scale 1:1000

FOR CONSTRUCTION

rev.	date	details	drwn	chkd
------	------	---------	------	------

James F Stephen Architects
Incorporating Baxter, Clark & Paul (Dundee)
Architecture - Interior Design - Landscape Design

Milton Studio

www.jfsa.co.uk

Glamis Angus DD8 1RG t. 01307 475000
5 Viewfield Pl. Stirling FK8 1NQ t. 01786 446939

Job Title
Camp 21 Heritage Self Catering Accommodation at Cultybraggan Camp, Comrie Perthshire
for Comrie Development Trust

Drawing Title
Hut 29 - Proposed Plan, Sections and Elevations
Commercial Let Unit

Scale.	1:50	Drwn.	DP
Original Size.	A1	Chkd.	DJR
© JFS Architects LLP	Date.	30/01/2020	

Drawing No.
4032-GA-321